


REV.	DATE:	DESCRIPTION	BY	CHK

ROBERT V. KISER, P.E.
 NEW JERSEY PROFESSIONAL ENGINEER
 NEW JERSEY LICENSE NO. 25674

IMPROVEMENTS TO BANK
 POE ROAD CONSTRUCTION DRAWINGS - PLAN AND PROFILE STA. 0+00 TO STA. 7+00
 MUNICIPALITY OF PRINCETON
 DEPARTMENT OF ENGINEERING
 MUNICIPAL BUILDING, 400 WITHERSPOON STREET, PRINCETON NJ 08540
 TELEPHONE: (609) 921-7077 FACSIMILE: (609) 688-2027

Date: DEC. 2015
 Scale: 1"=15'
 Drawn: FAS
 Check: NONE
 View: PLAN 1
 Job#: BANK
 Dwg: PP1

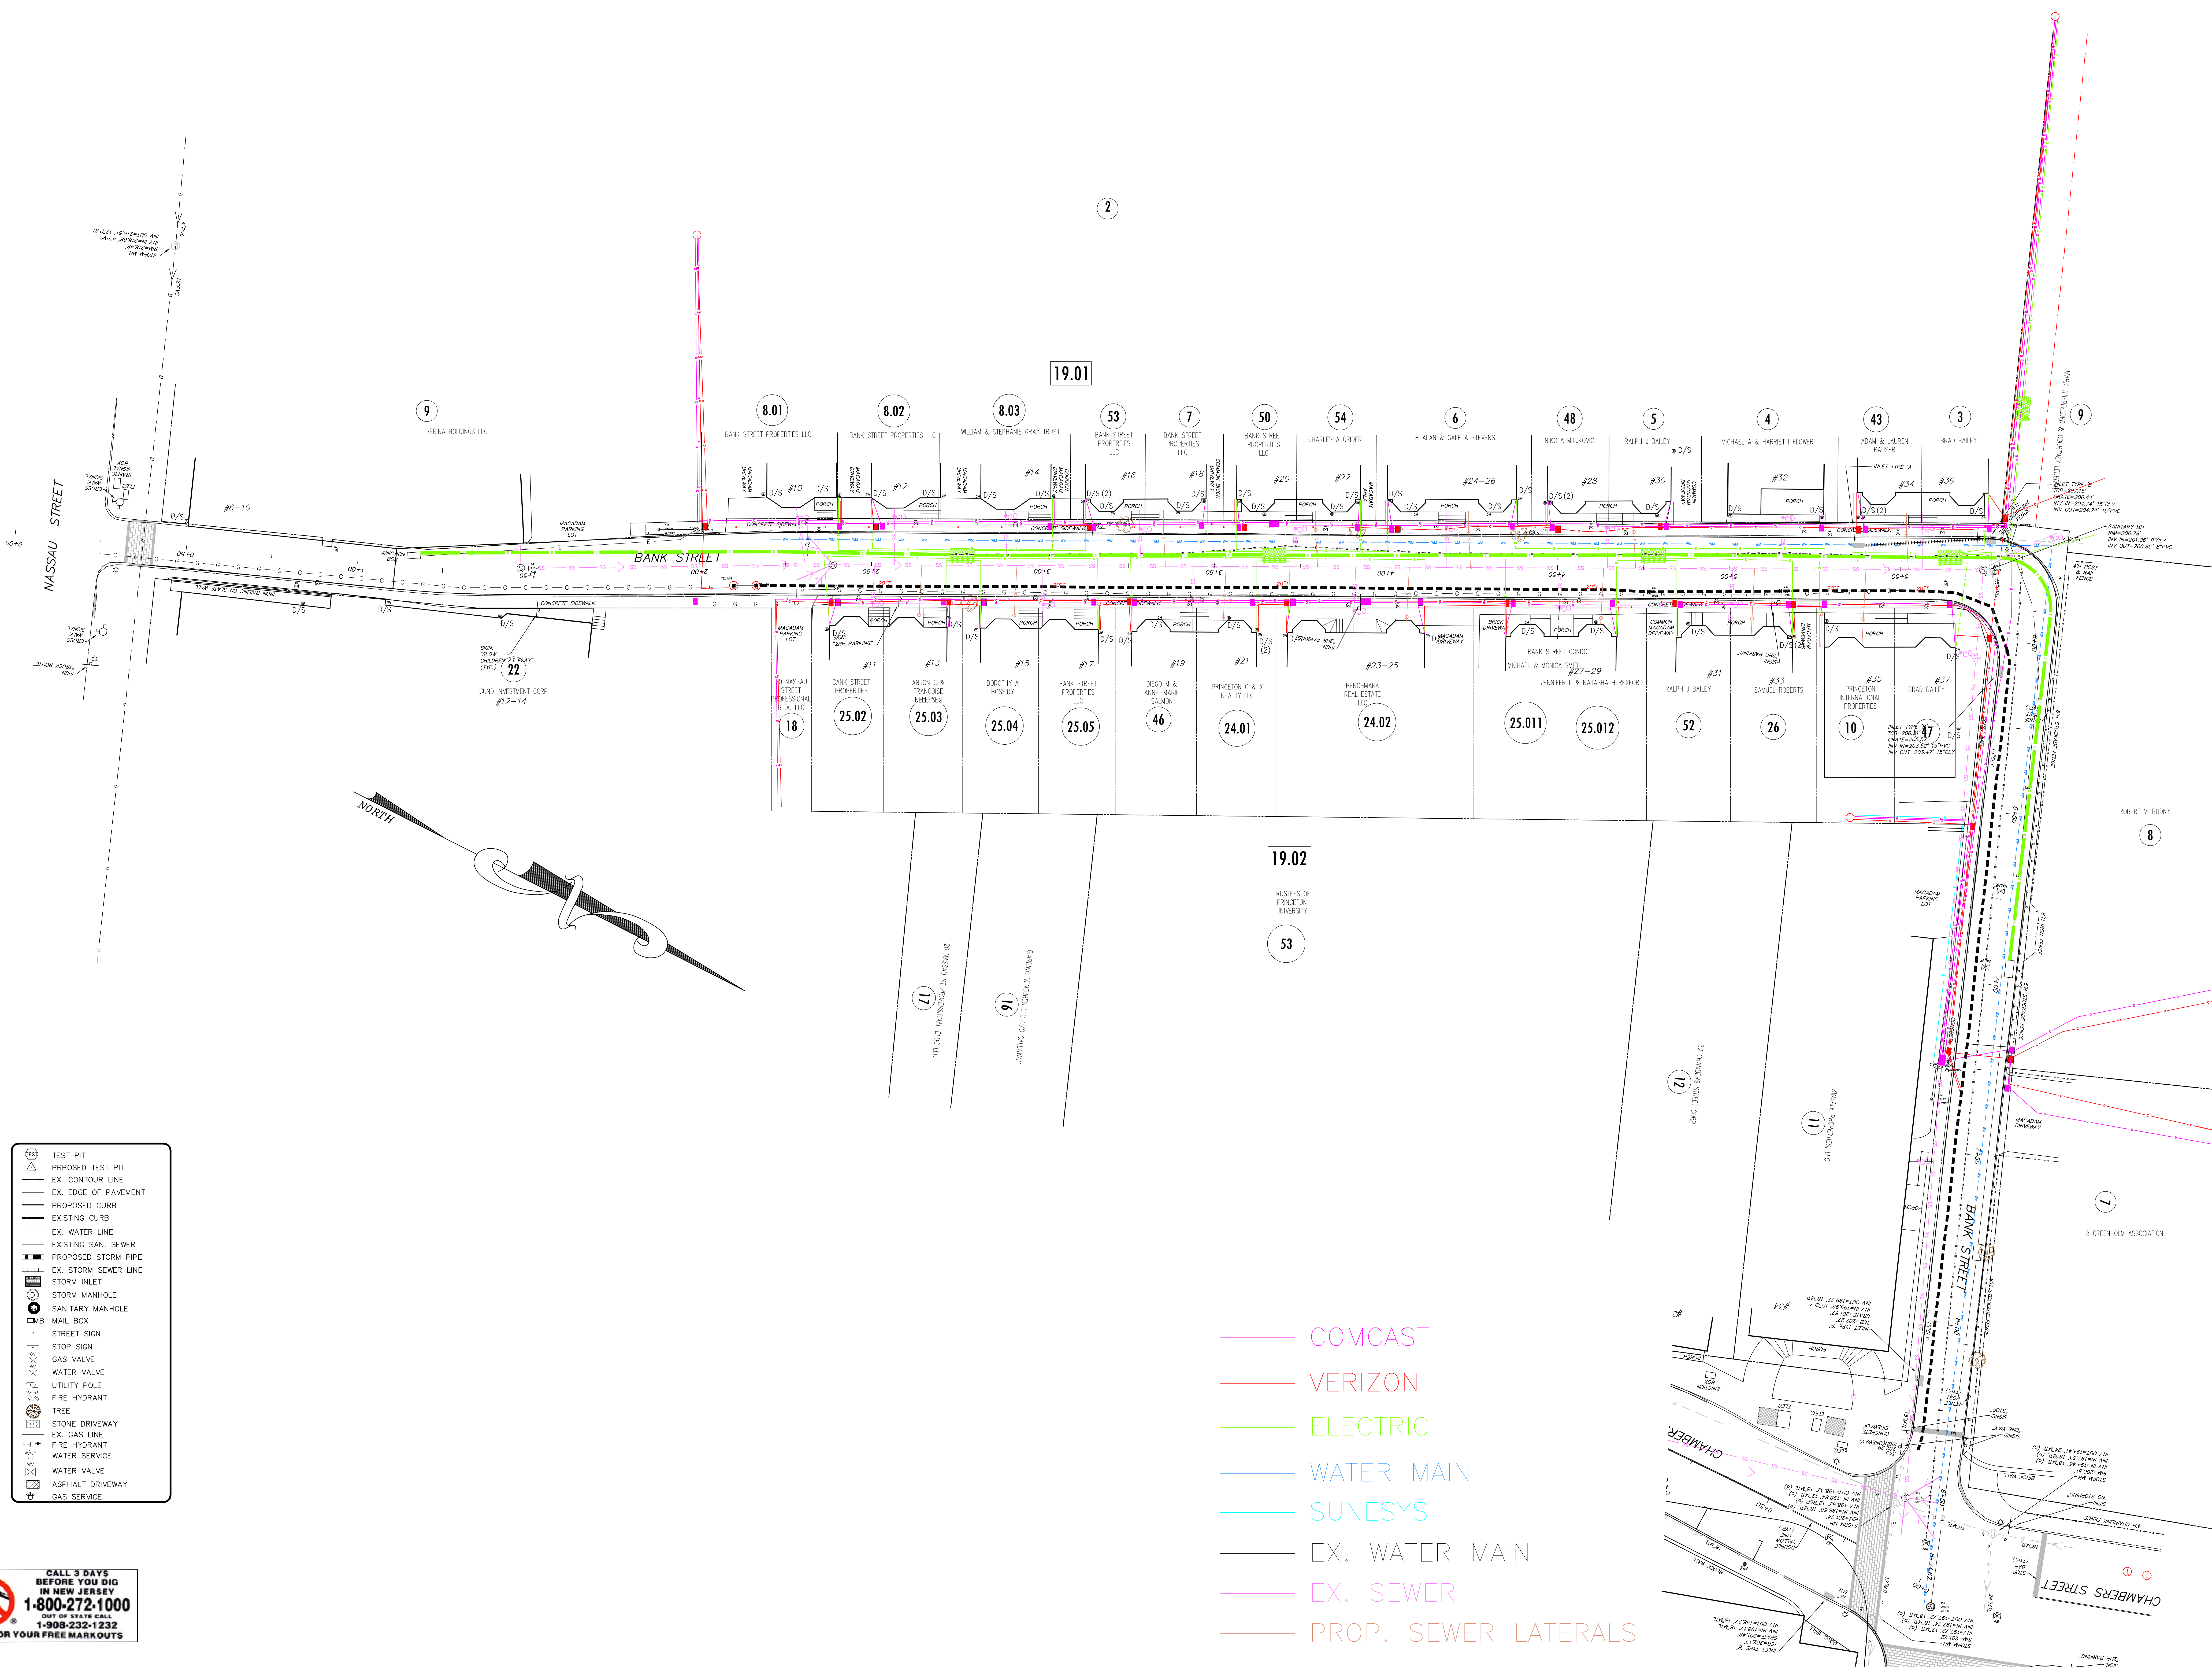

- TEST PIT
- PROPOSED TEST PIT
- EX. CONTOUR LINE
- EX. EDGE OF PAVEMENT
- PROPOSED CURB
- EXISTING CURB
- EX. WATER LINE
- EXISTING SAN. SEWER
- PROPOSED STORM PIPE
- EX. STORM SEWER LINE
- STORM INLET
- STORM MANHOLE
- SANITARY MANHOLE
- MAIL BOX
- STREET SIGN
- STOP SIGN
- GAS VALVE
- WATER VALVE
- UTILITY POLE
- FIRE HYDRANT
- TREE
- STONE DRIVEWAY
- EX. GAS LINE
- FIRE HYDRANT
- WATER SERVICE
- WATER VALVE
- ASPHALT DRIVEWAY
- GAS SERVICE

- COMCAST
- VERIZON
- ELECTRIC
- WATER MAIN
- SUNESYS
- EX. WATER MAIN
- EX. SEWER
- PROP. SEWER LATERALS

CALL 3 DAYS BEFORE YOU DIG IN NEW JERSEY 1-800-272-1000
 OUT OF STATE CALL 1-908-232-1232
 CALL FOR YOUR FREE MARKOUTS

Date

Robert V. Kiser NJPE # 25674